
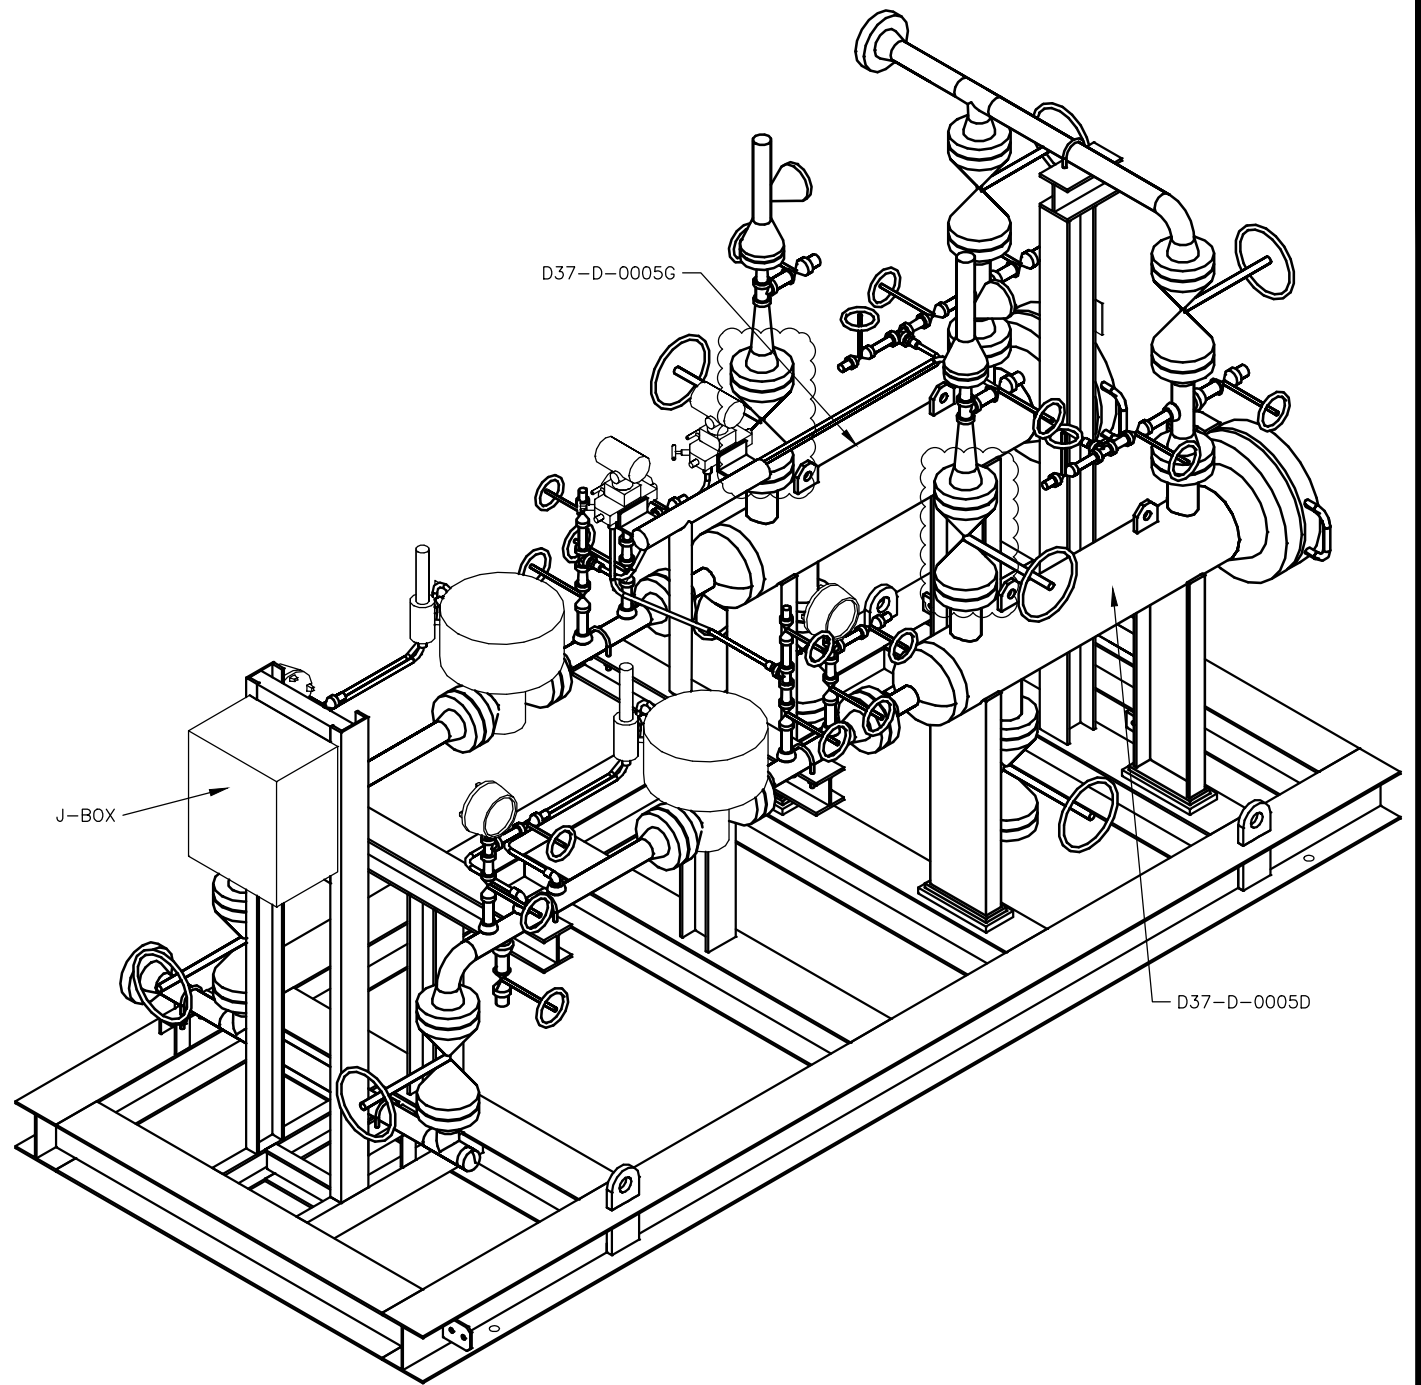


○ TAG: D37-D-0005A
DESCRIPTION: BLACK POWDER FILTRATION SKID
CUSTOMER: GULF CONSOLIDATED CONTRACTORS
USER: SAUDI ARAMCO
PROJECT: SRG-2EXTENSION
CUST. PO: 4510004521
IFS JOB: 25129 YEAR: 2015
INTEGRATED FLOW SOLUTIONS, TYLER, TX, USA
PH.: 001-903-595-6511
○ EMAIL: SUPPORT@IFSOLUTIONS.COM

SKID IDENTIFICATION TAG
4" x 6" STAINLESS STEEL

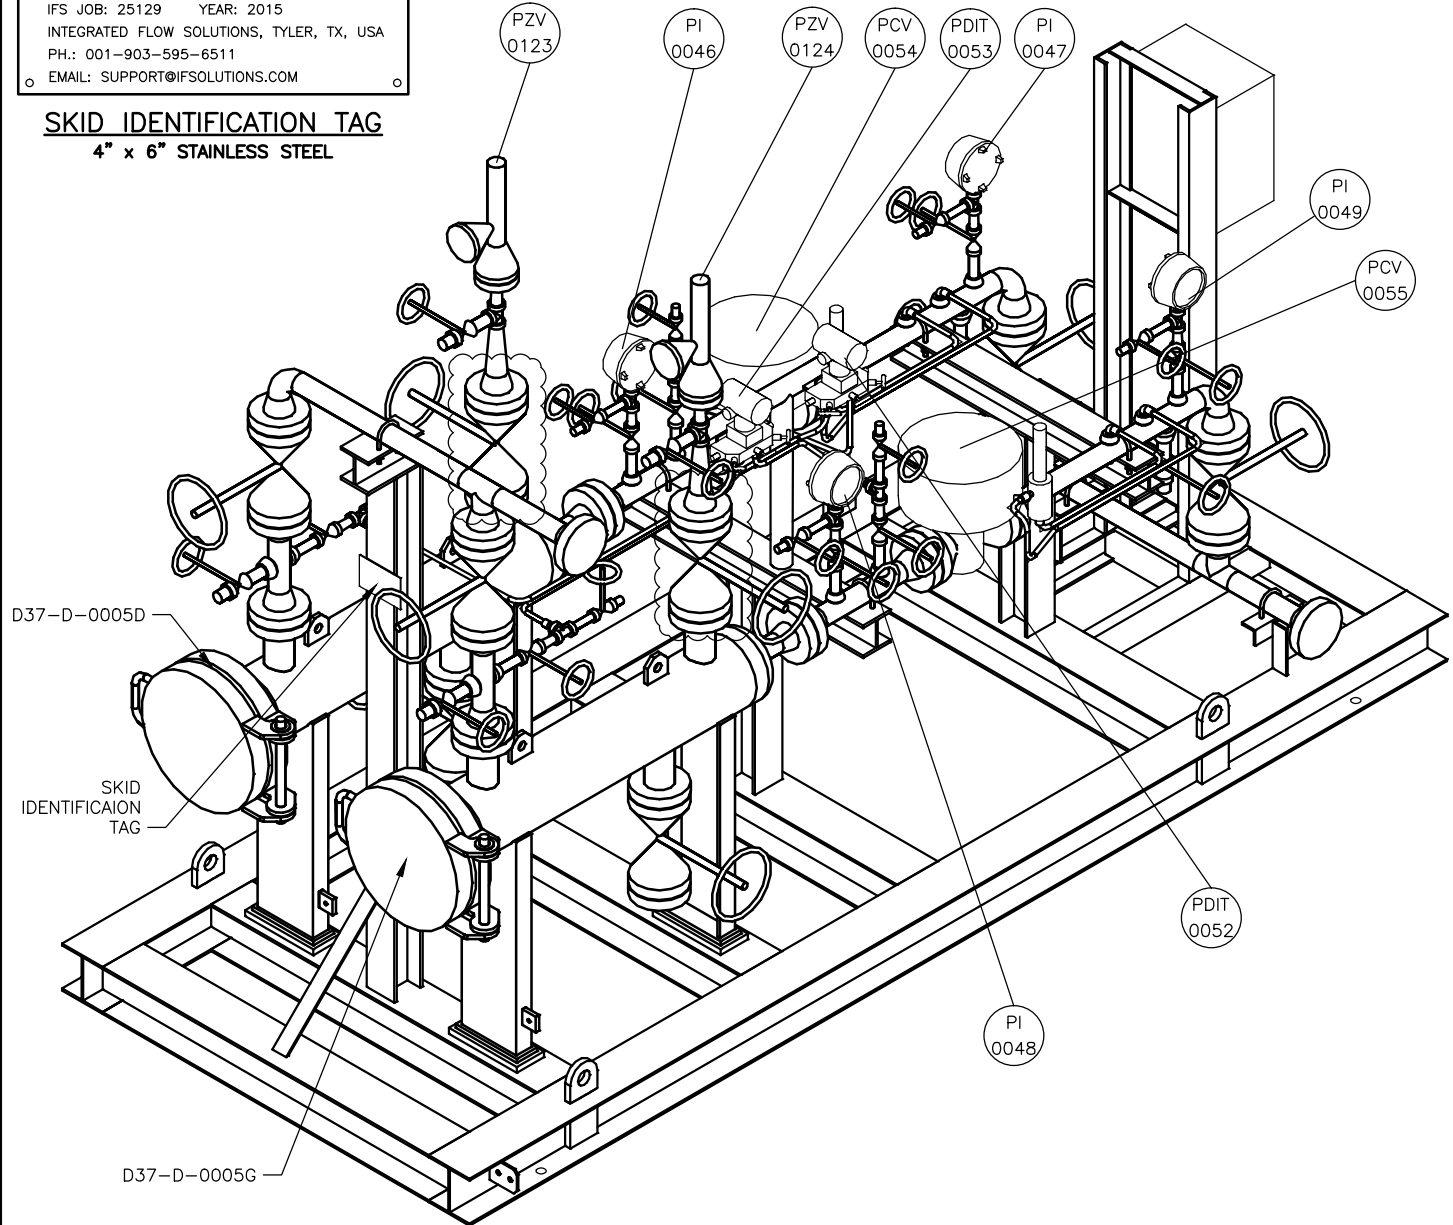

ISO VIEWS
(FOR REFERENCE ONLY)

Gas Operated Valve (GOV) Black Powder Filtration Package

www.IFSolutions.com

- NOTES:
1. FOR PLAN VIEW SEE DWG. NO.: G-25129-01.
 2. FOR ELEVATION VIEW SEE DWG. NO.: G-25129-02.
 3. FOR END VIEW SEE DWG. NO.: G-25129-03.
 4. FOR P&ID SEE DWG. NO.: P-25129-02
 5. FOR CONDUIT LAYOUT SEE DWG. NO.: CL-25129-01 TO 04
 6. FOR J-BOX WIRING SEE DWG. NO.: W1-25129-01



**INTEGRATED
FLOW SOLUTIONS**
6461 REYNOLDS RD, TYLER, TEXAS, USA 75708
PHONE NUMBER: +1 (903) 595-6511
EMAIL: SUPPORT@IFSOLUTIONS.COM

THIS DRAWING IS THE PROPERTY OF INTEGRATED FLOW SOLUTIONS AND SHALL NOT BE REPRODUCED, COPIED, LENT, NOR USED FOR ANY PURPOSE OTHER THAN THAT WHICH IT IS FURNISHED EXCEPT BY WRITTEN PERMISSION.

REV.	DATE	DESCRIPTION	DES	ENG
D	19JUN15	PER CUSTOMER COMMENTS	HG	HC
C	21MAY15	PER CUSTOMER COMMENTS	HG	HC
B	19DEC14	PER CUSTOMER COMMENTS	MCS	HC
A	20OCT14	ISSUED FOR CUSTOMER APPROVAL	JG	HC

PROJECT: SRG-2EXTENSION
CUSTOMER NAME: GULF CONSOLIDATED CONTRACTORS CO.
END USER: SAUDI ARAMCO
SYSTEM DESCRIPTION: BLACK POWDER FILTRATION SKID
TAG NUMBER: D37-D-0005A AT KM 91.208
CUSTOMER PO#: 4510004521
ESTIMATED DRY WEIGHT: 4000 lb [1814 kg]
ESTIMATED OPERATING WEIGHT: 4010 lb [1819 kg]

**GENERAL ARRANGEMENT
BLACK POWDER FILTRATION SKID**

CLIENT No.: —

SCALE: NONE	SECTION	JOB	SHEET	TOTAL SHEETS	REV.
PM.: RC	G - 25129-04		04	04	D